


96

LED MARKER LIGHTS
WHELEN SCENE AND WARNING LIGHTS WITH FLANGES

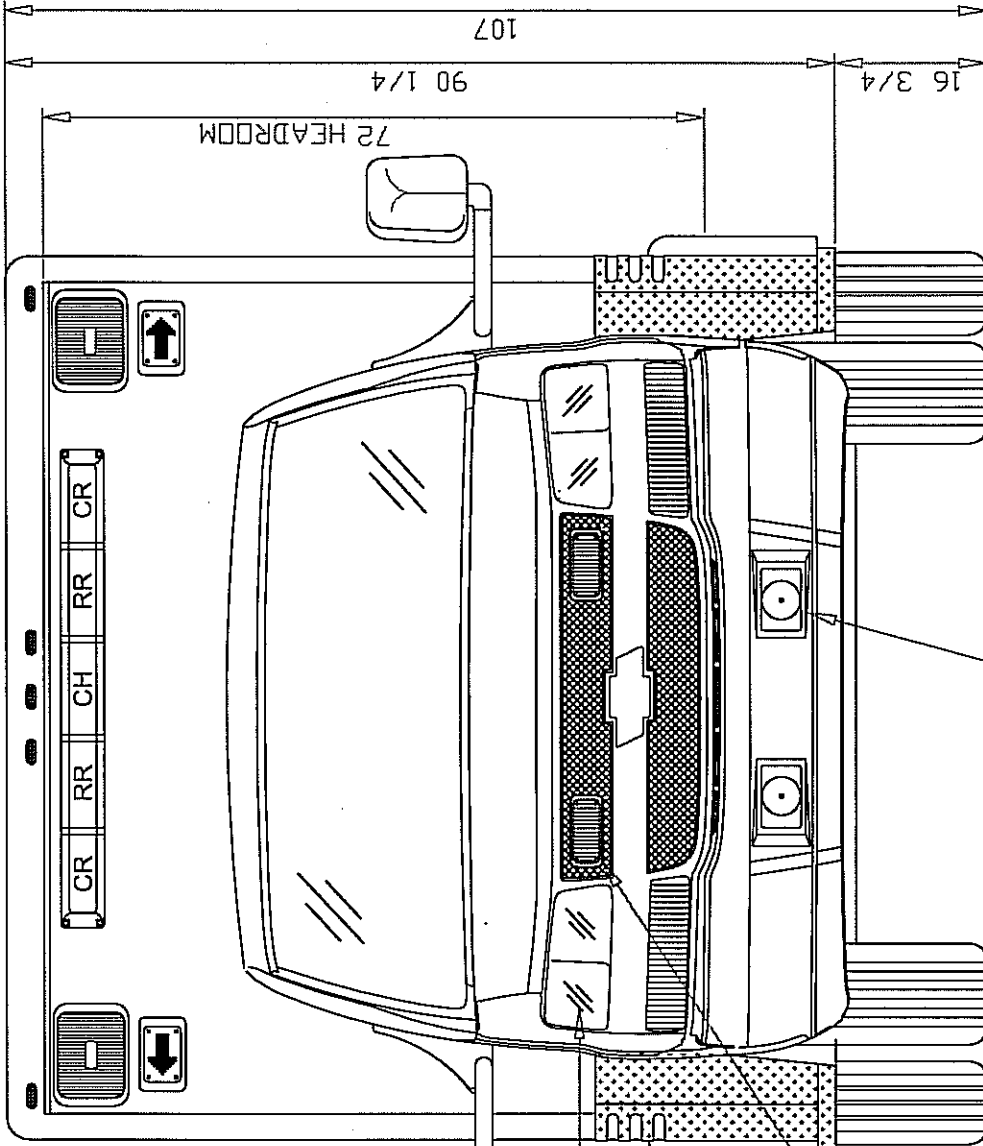

VELVAC
#2020
MIRRORS

CODE3 711
WIG-WAG
HEADLIGHT
FLASHER

WHELEN 500 SERIES
RED SUPER LEDS

CAST SAD4313
SIREN SPEAKERS

DRAWN BY: *Intital* REVISIONS


DATE: 01-01-06

Drawing is representative only. Dimensions shown are approximate and may vary from the completed vehicle. See the actual drawing.

MARQUE ~ ~ ~ AMBULANCES

DRAWING TITLE: FRONT EXTERIOR VIEW - 72" H.H.R.
TYPE/MODEL/CHASSIS: TYPE III-164 BIRGADIER -G4500
DEALER/CUSTOMER/DEALER/CUSTOMER NAME
UNIT NUMBER: ##### PRINT NUMBER: T3-164CMDO-001


LED MARKER LIGHTS
WHELEN SCENE AND WARNING LIGHTS WITH FLANGES

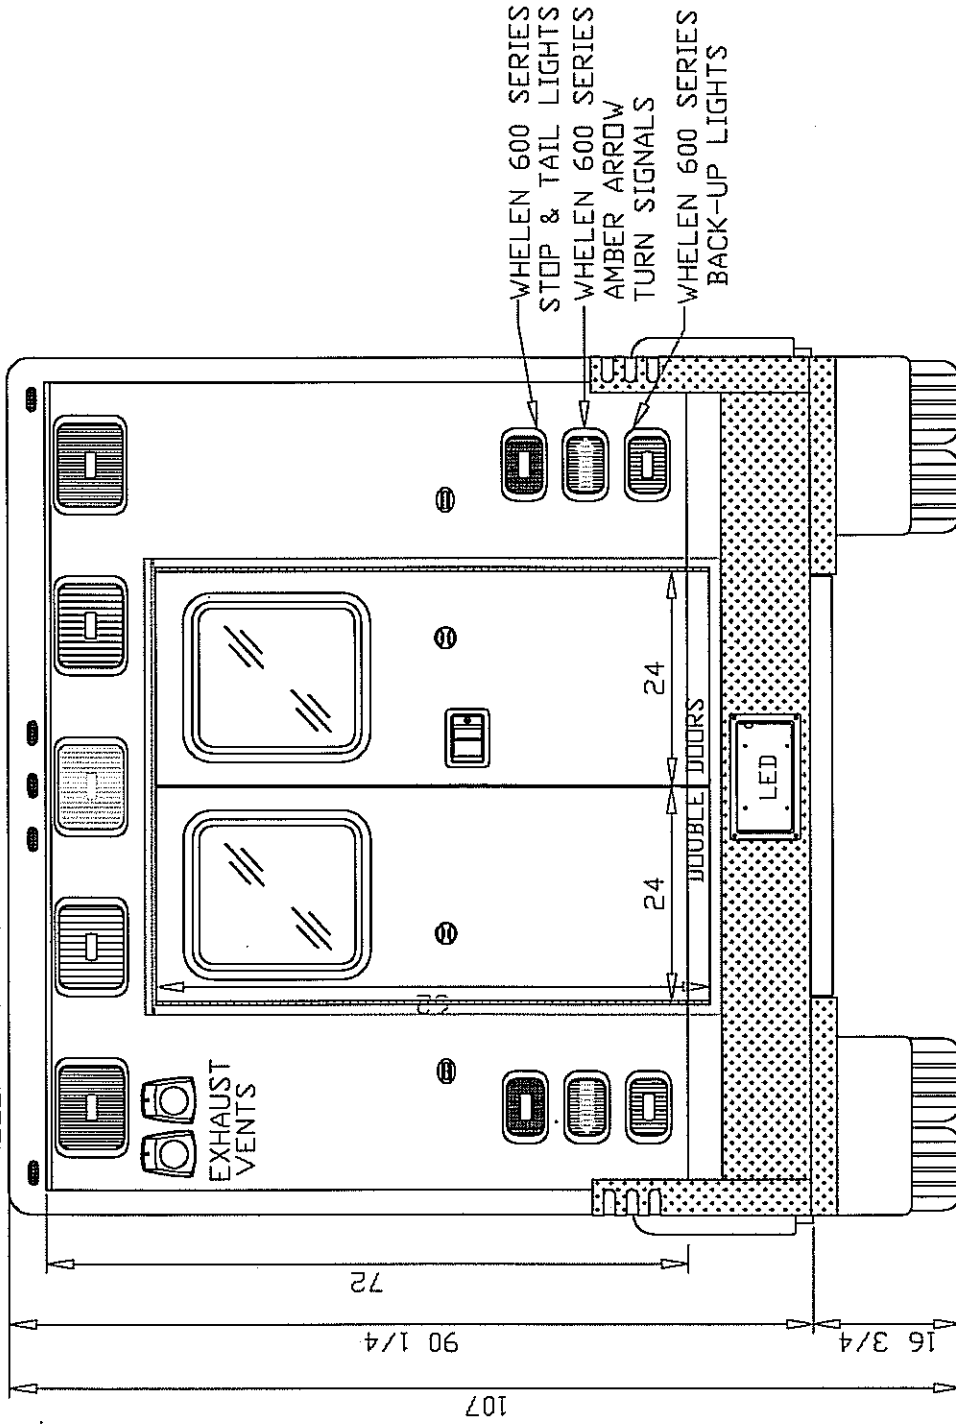

DRAWN BY: <i>mettaz</i>	REVISIONS	DRAWING TITLE: REAR EXTERIOR VIEW - 72' H.R.
DATE: 01-01-06	MARQUE ~ ~ ~	TYPE/MODEL/CHASSIS: TYPE III-164 BRIGADIER-G4500
Drawing is representative only - Dimensions shown are for information and may vary from the completed vehicle. DO NOT scale this drawing.	AMBUANCES	DEALER / CUSTOMER: DEALER/CUSTOMER NAME
		UNIT NUMBER: #####
		PRINT NUMBER: T3-164C/MDO-002

170

LED MARKER LIGHTS
WHEEL SCENE AND WARNING LIGHTS WITH FLANGES

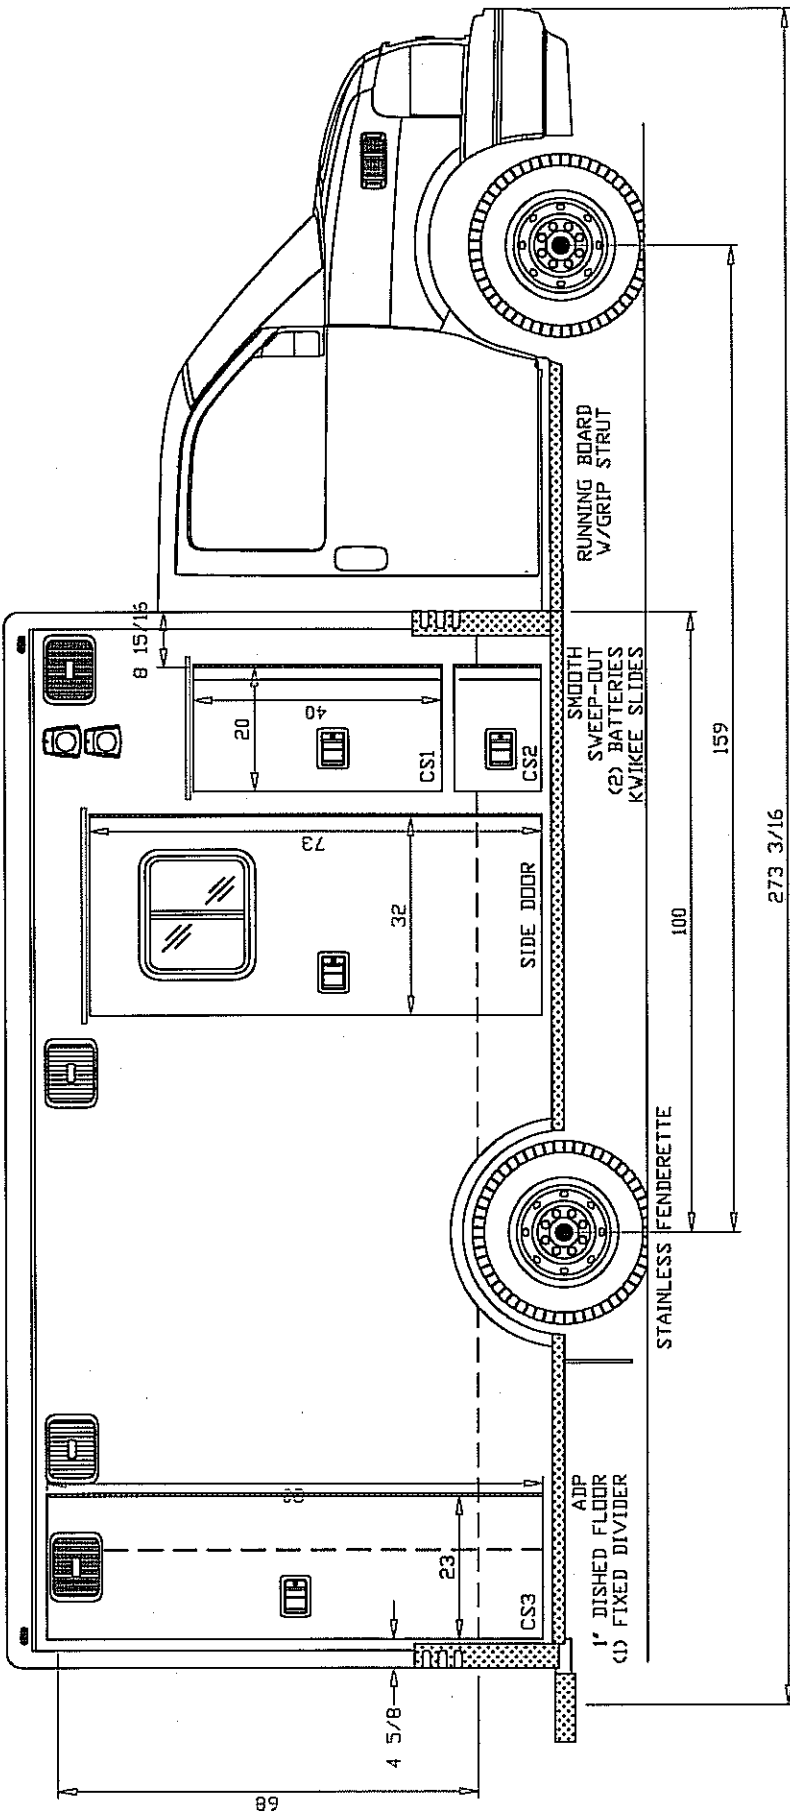

DRAWN BY: *Tacticals* REVISIONS

DATE: 01-01-06


Drawing is representative only - Dimensions shown may vary from the completed vehicle DO NOT scale this drawing!

MARQUE ~ ~ ~ AMBULANCES

DRAWING TITLE: CURBSIDE EXTERIOR VIEW - 72' H.R.
TYPE/MODEL/CHASSIS: TYPE III-164 BRIGADIER-G4500
DEALER / CUSTOMER: DEALER/CUSTOMER NAME
UNIT NUMBER: #####
PRINT NUMBER: T3-164CMD0-003

170

LED MARKER LIGHTS
WHEEL SCENE AND WARNING LIGHTS WITH FLANGES

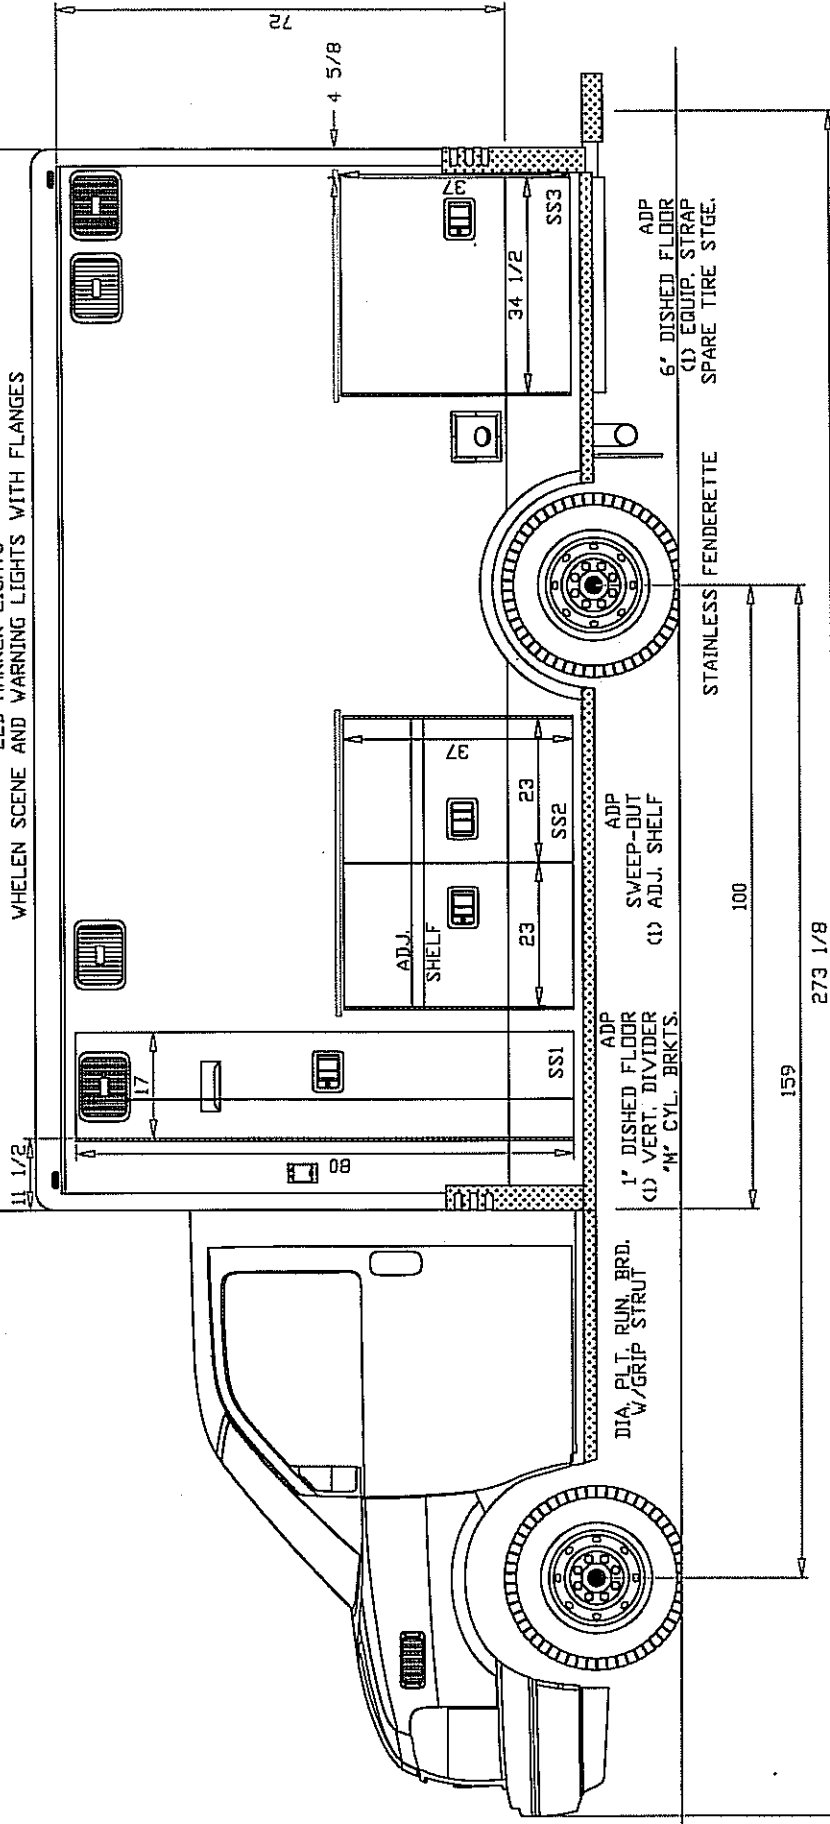


DRAWN BY: *T. H. H. H.*

DATE: 01-01-06

Drawing is representative only - Dimensions shown are approximate and may vary from the completed vehicle DO NOT scale this drawing!

REVISIONS

MARQUE ~ ~ ~  AMBULANCES


DRAWING TITLE: STREETSIDE EXTERIOR VIEW - 72" H.R.

TYPE/MODEL/CHASSIS: TYPE III-164 BRIGADIER-G4500

DEALER / CUSTOMER: DEALER/CUSTOMER NAME

UNIT NUMBER: ##### PRINT NUMBER: T3-164CMDO-004

DUCTED
HEAT/AC

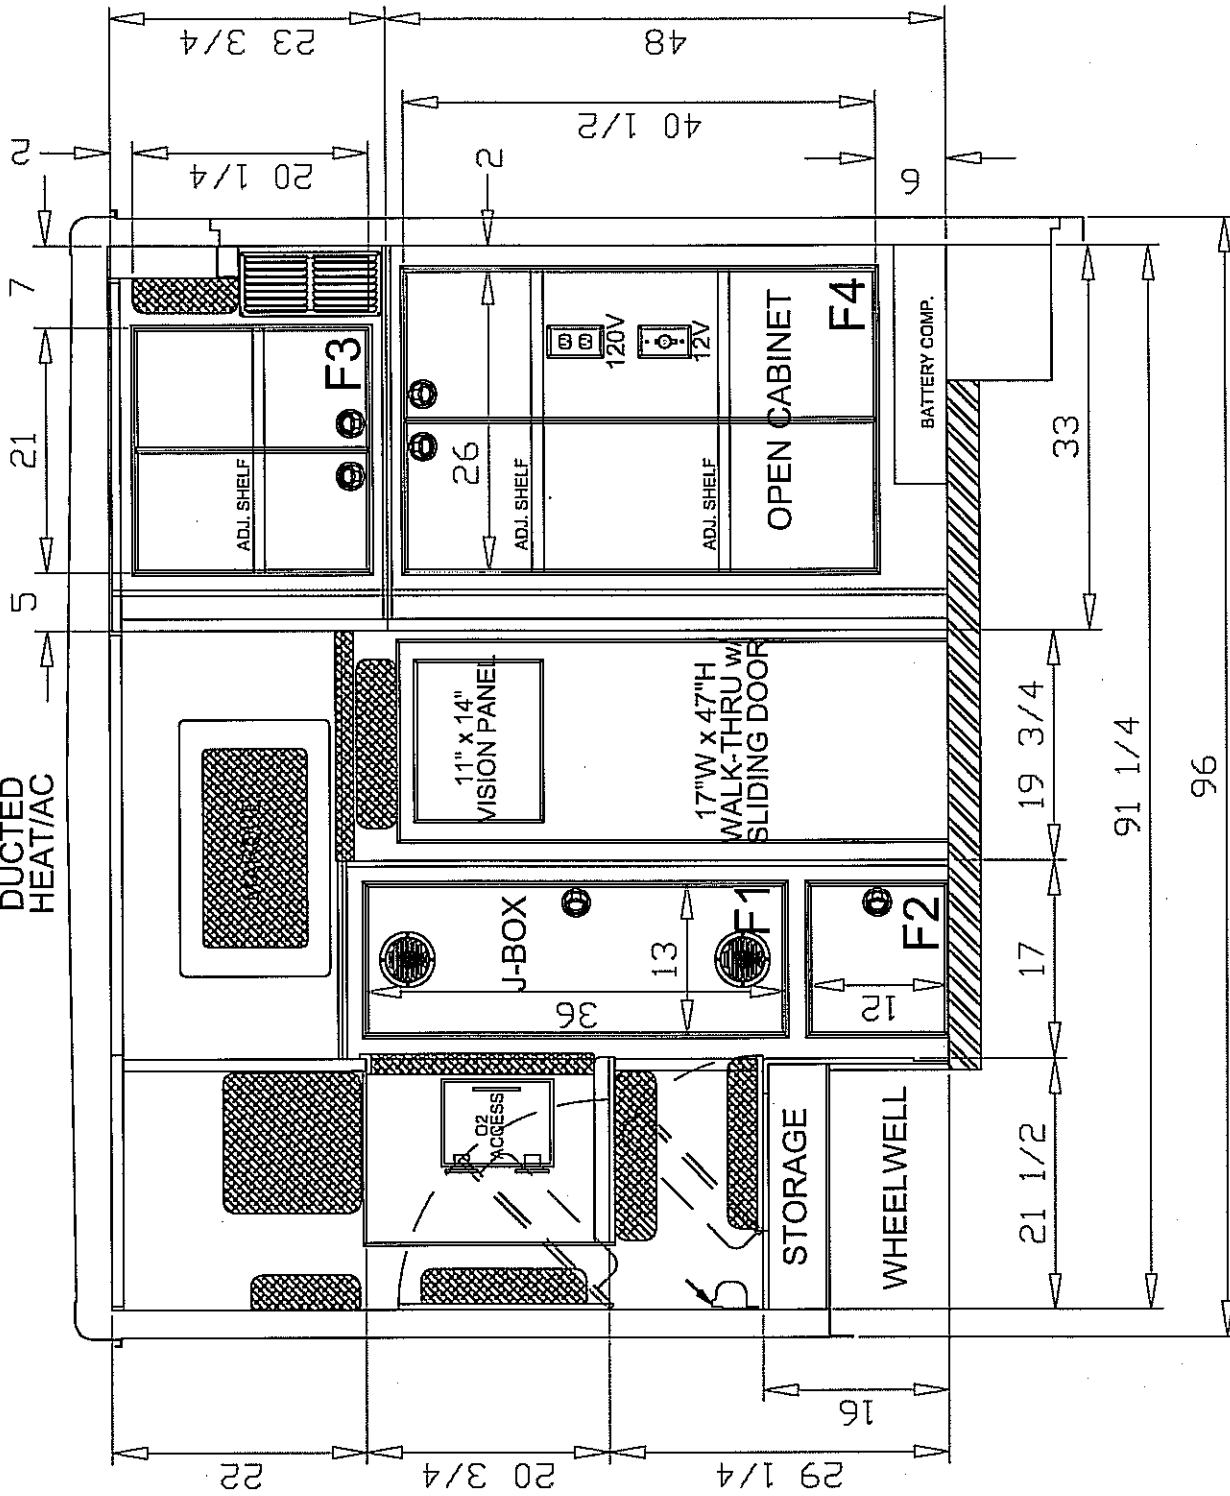


DRAWN BY: *Intelside* REVISIONS

DATE: 01-01-06


Drawing is representative only - Dimensions shown are approximate and may vary from the completed vehicle DO NOT scale the drawing.

MARQUE ~ ~ ~ AMBULANCES


DRAWING TITLE: FRONT INTERIOR VIEW - 72' H.I.R.
 MODEL/TYPE/CHASSIS: TYPE III - 164 BRIGADIER
 DEALER/CUSTOMER/DEALER/CUSTOMER NAME
 UNIT NUMBER: ##### PRINT NUMBER: T3-164CMDO-005

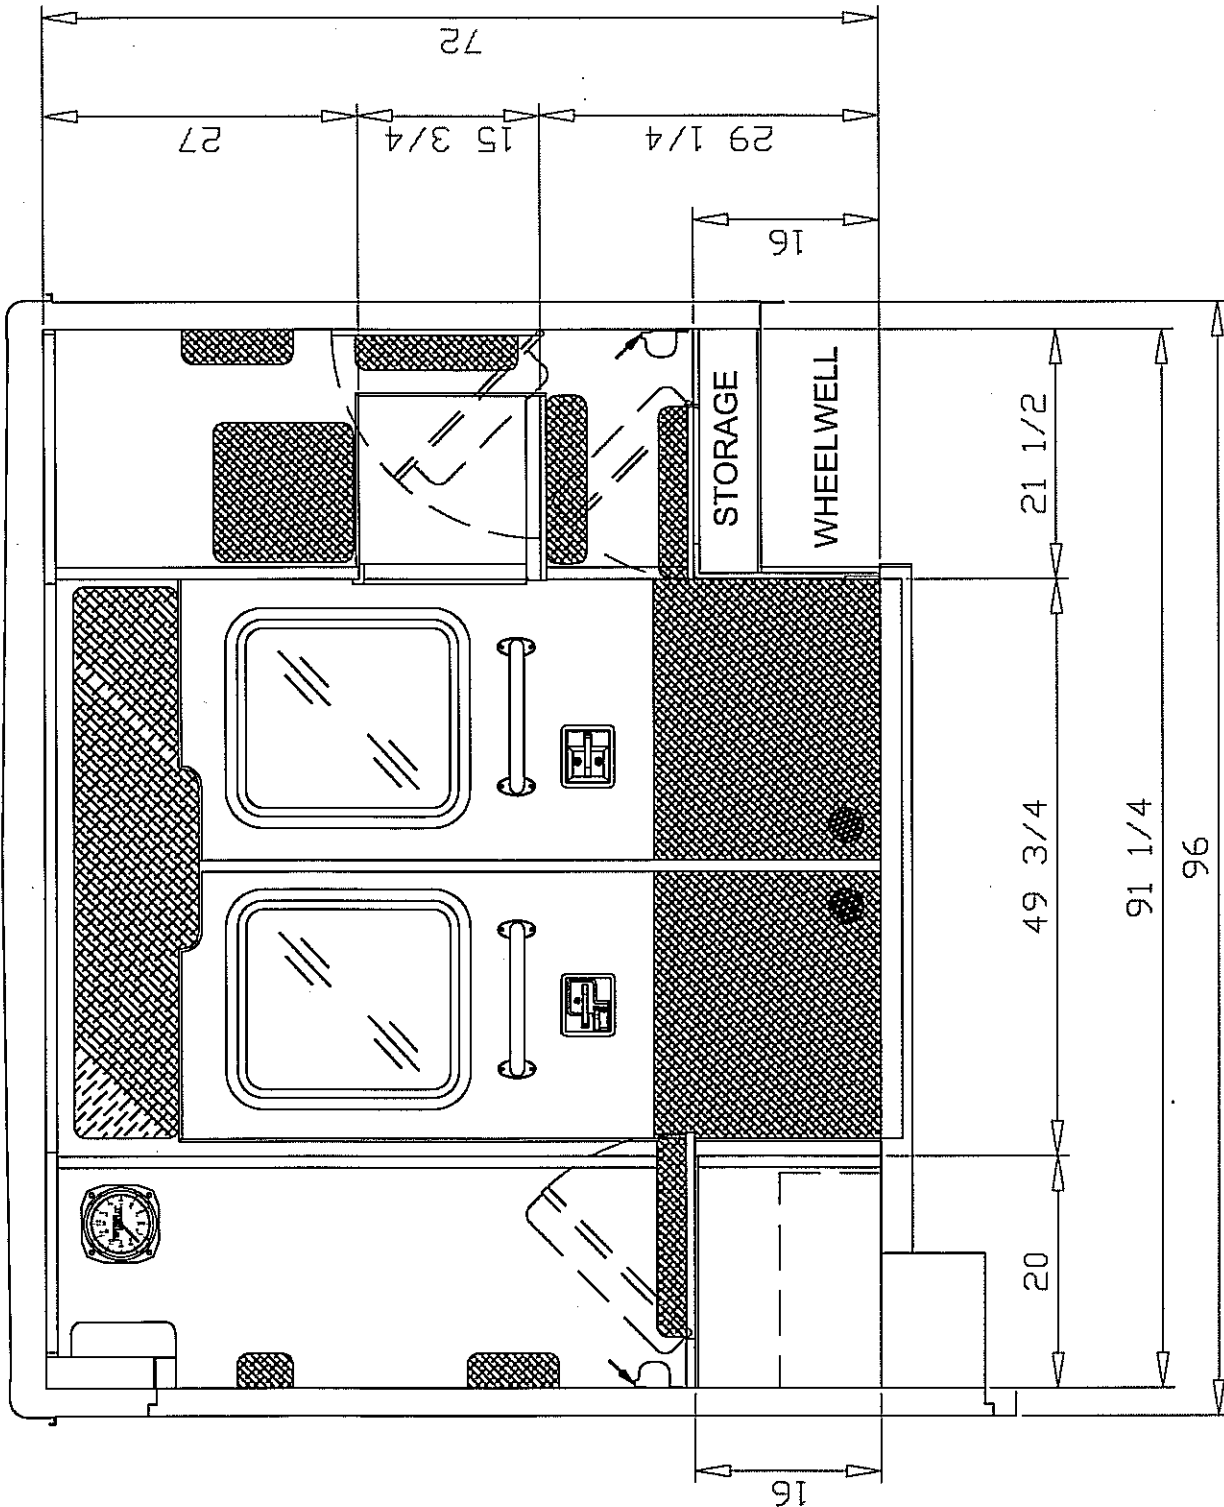


DRAWING TITLE: REAR INTERIOR VIEW - 72' H.R.
 MODEL/TYPE/CHASSIS: TYPE III - 164 BRIGADIER
 DEALER / CUSTOMER/DEALER/CUSTOMER NAME
 UNIT NUMBER: ##### PRINT NUMBER: T3-164C/MDO-006

MARQUE  AMBULANCES

DRAWN BY:	REVISIONS
<i>Intitala</i>	
DATE: 01-01-06	
<small>Drawing is representative only - Dimensions shown are approximate and may vary from the completed vehicle. DO NOT scale this drawing!</small>	

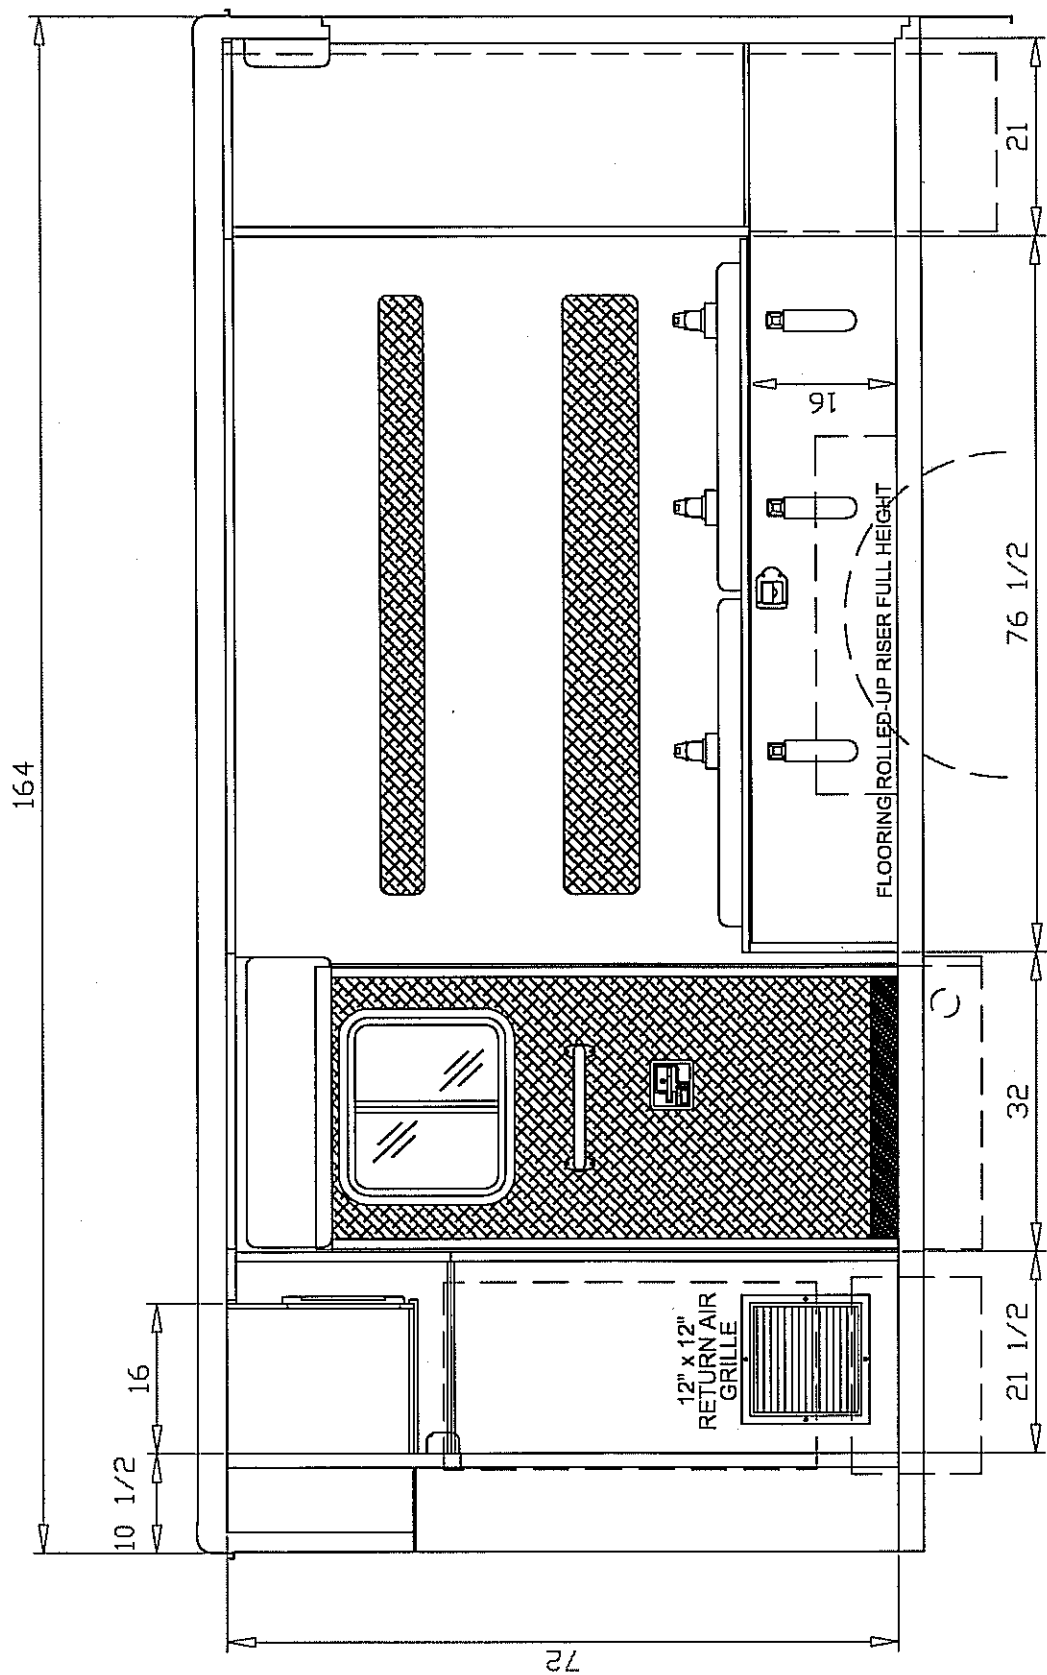


DRAWN BY: <i>9rectals</i>	REVISIONS	MARQUE ~ ~ ~ AMBULANCES	DRAWING TITLE: CURBSIDE INTERIOR VIEW - 72' H.R.
DATE: 01-01-06			MODEL/TYPE/CHASSIS: TYPE III - 164 BRIGADIER
Drawing is representative only. Dimensions shown are approximate and may vary from the completed vehicle. DO NOT scale this drawing!			DEALER/CUSTOMER/DEALER/CUSTOMER NAME
			UNIT NUMBER: ##### PRINT NUMBER: T3-164CMDO-007

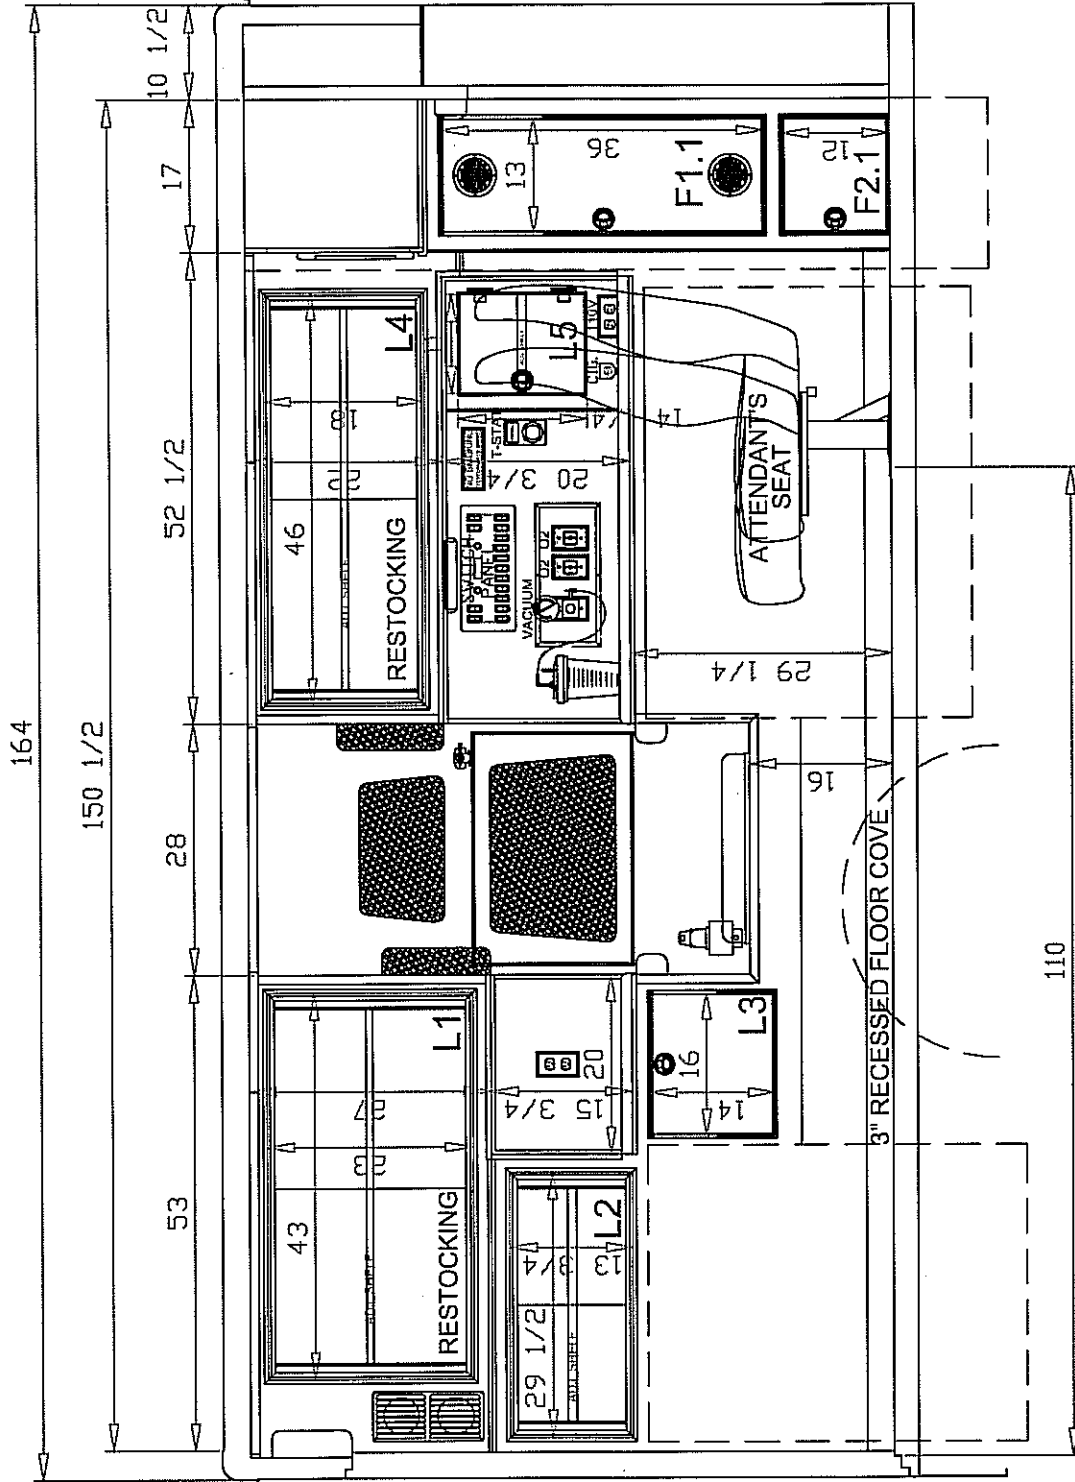

TO MOUNTING HOLES

DRAWN BY: <i>Inticks</i>	REVISIONS	DRAWING TITLE: STREETSIDE INTERIOR VIEW - 72' H.R.
DATE: 01-01-06	MARQUE ~ ~ ~	MODEL/TYPE/CHASSIS: TYPE III - 164 BRIGADIER
<small>Drawing is for reference only. Dimensions shown DO NOT scale this drawing!</small>	AMBULANCES	DEALER / CUSTOMER: DEALER/CUSTOMER NAME
		UNIT NUMBER: ##### PRINT NUMBER: T3-164CMD0-008

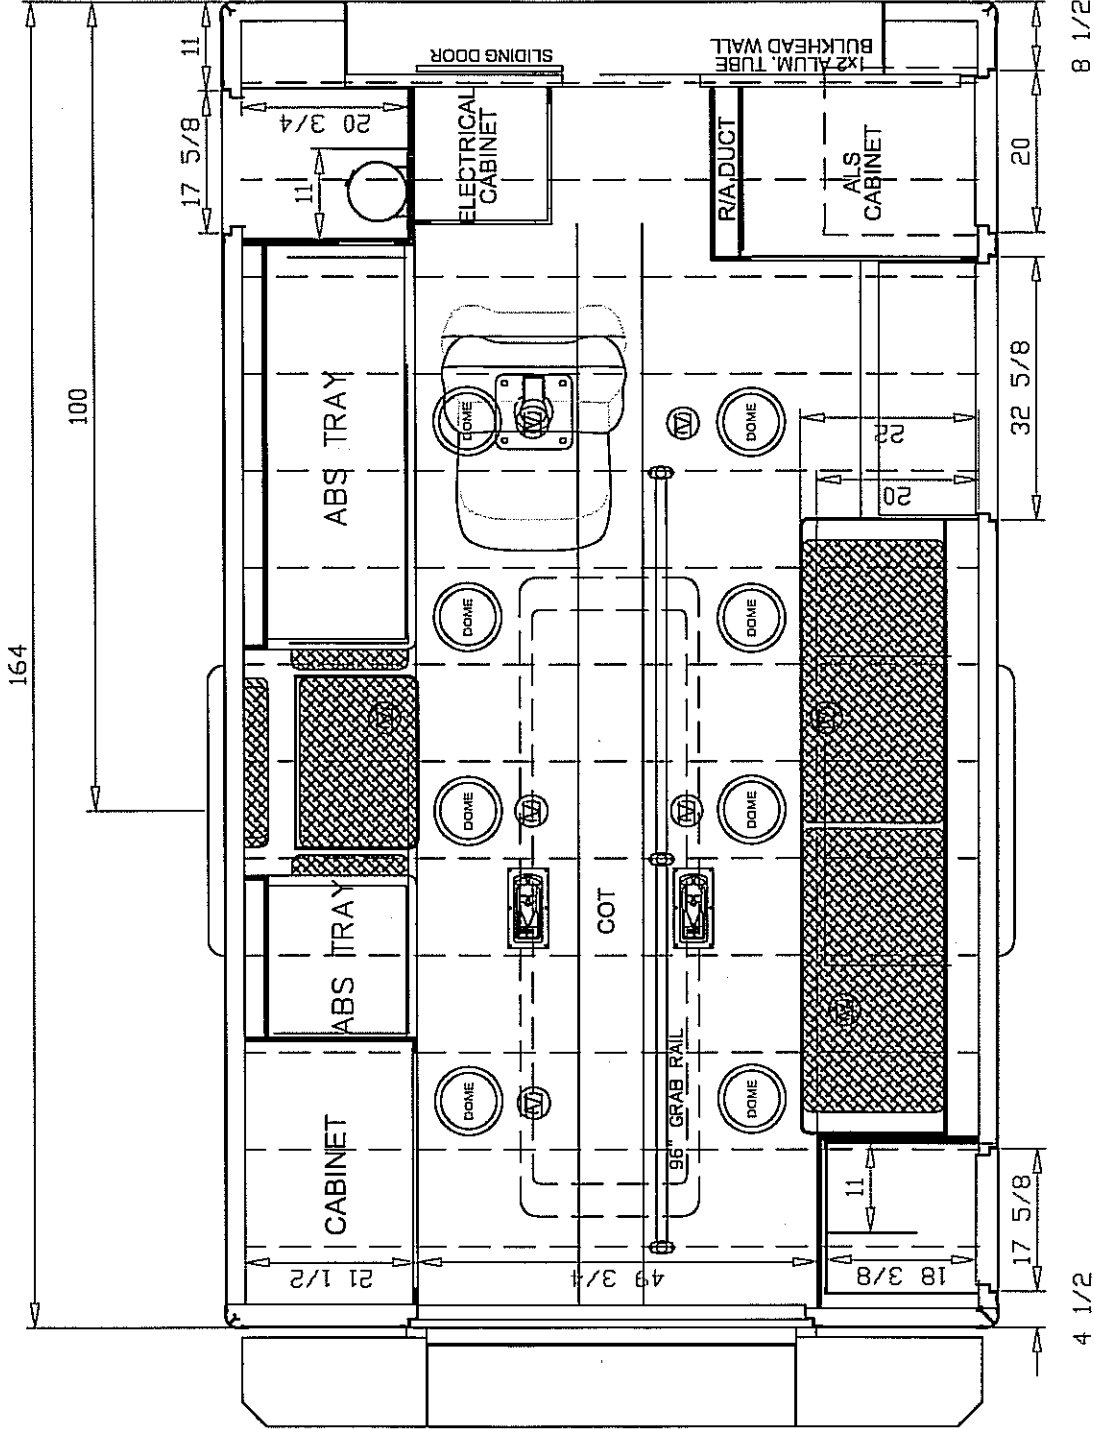

DRAWN BY: <i>Initials</i>	REVISIONS	DRAWING TITLE: FLOOR PLAN
DATE: 01-01-06		TYPE/MODEL/CHASSIS: TYPE III - 164 BRIGADIER
<small>Drawing is representative only - Dimensions shown are approximate and may vary from the completed vehicle. DO NOT scale this drawing!</small>		DEALER / CUSTOMER: DEALER/CUSTOMER NAME
		UNIT NUMBER: #####
		PRINT NUMBER: T3-164CMD0-009

MARQUE ~ ~ ~ AMBULANCES